



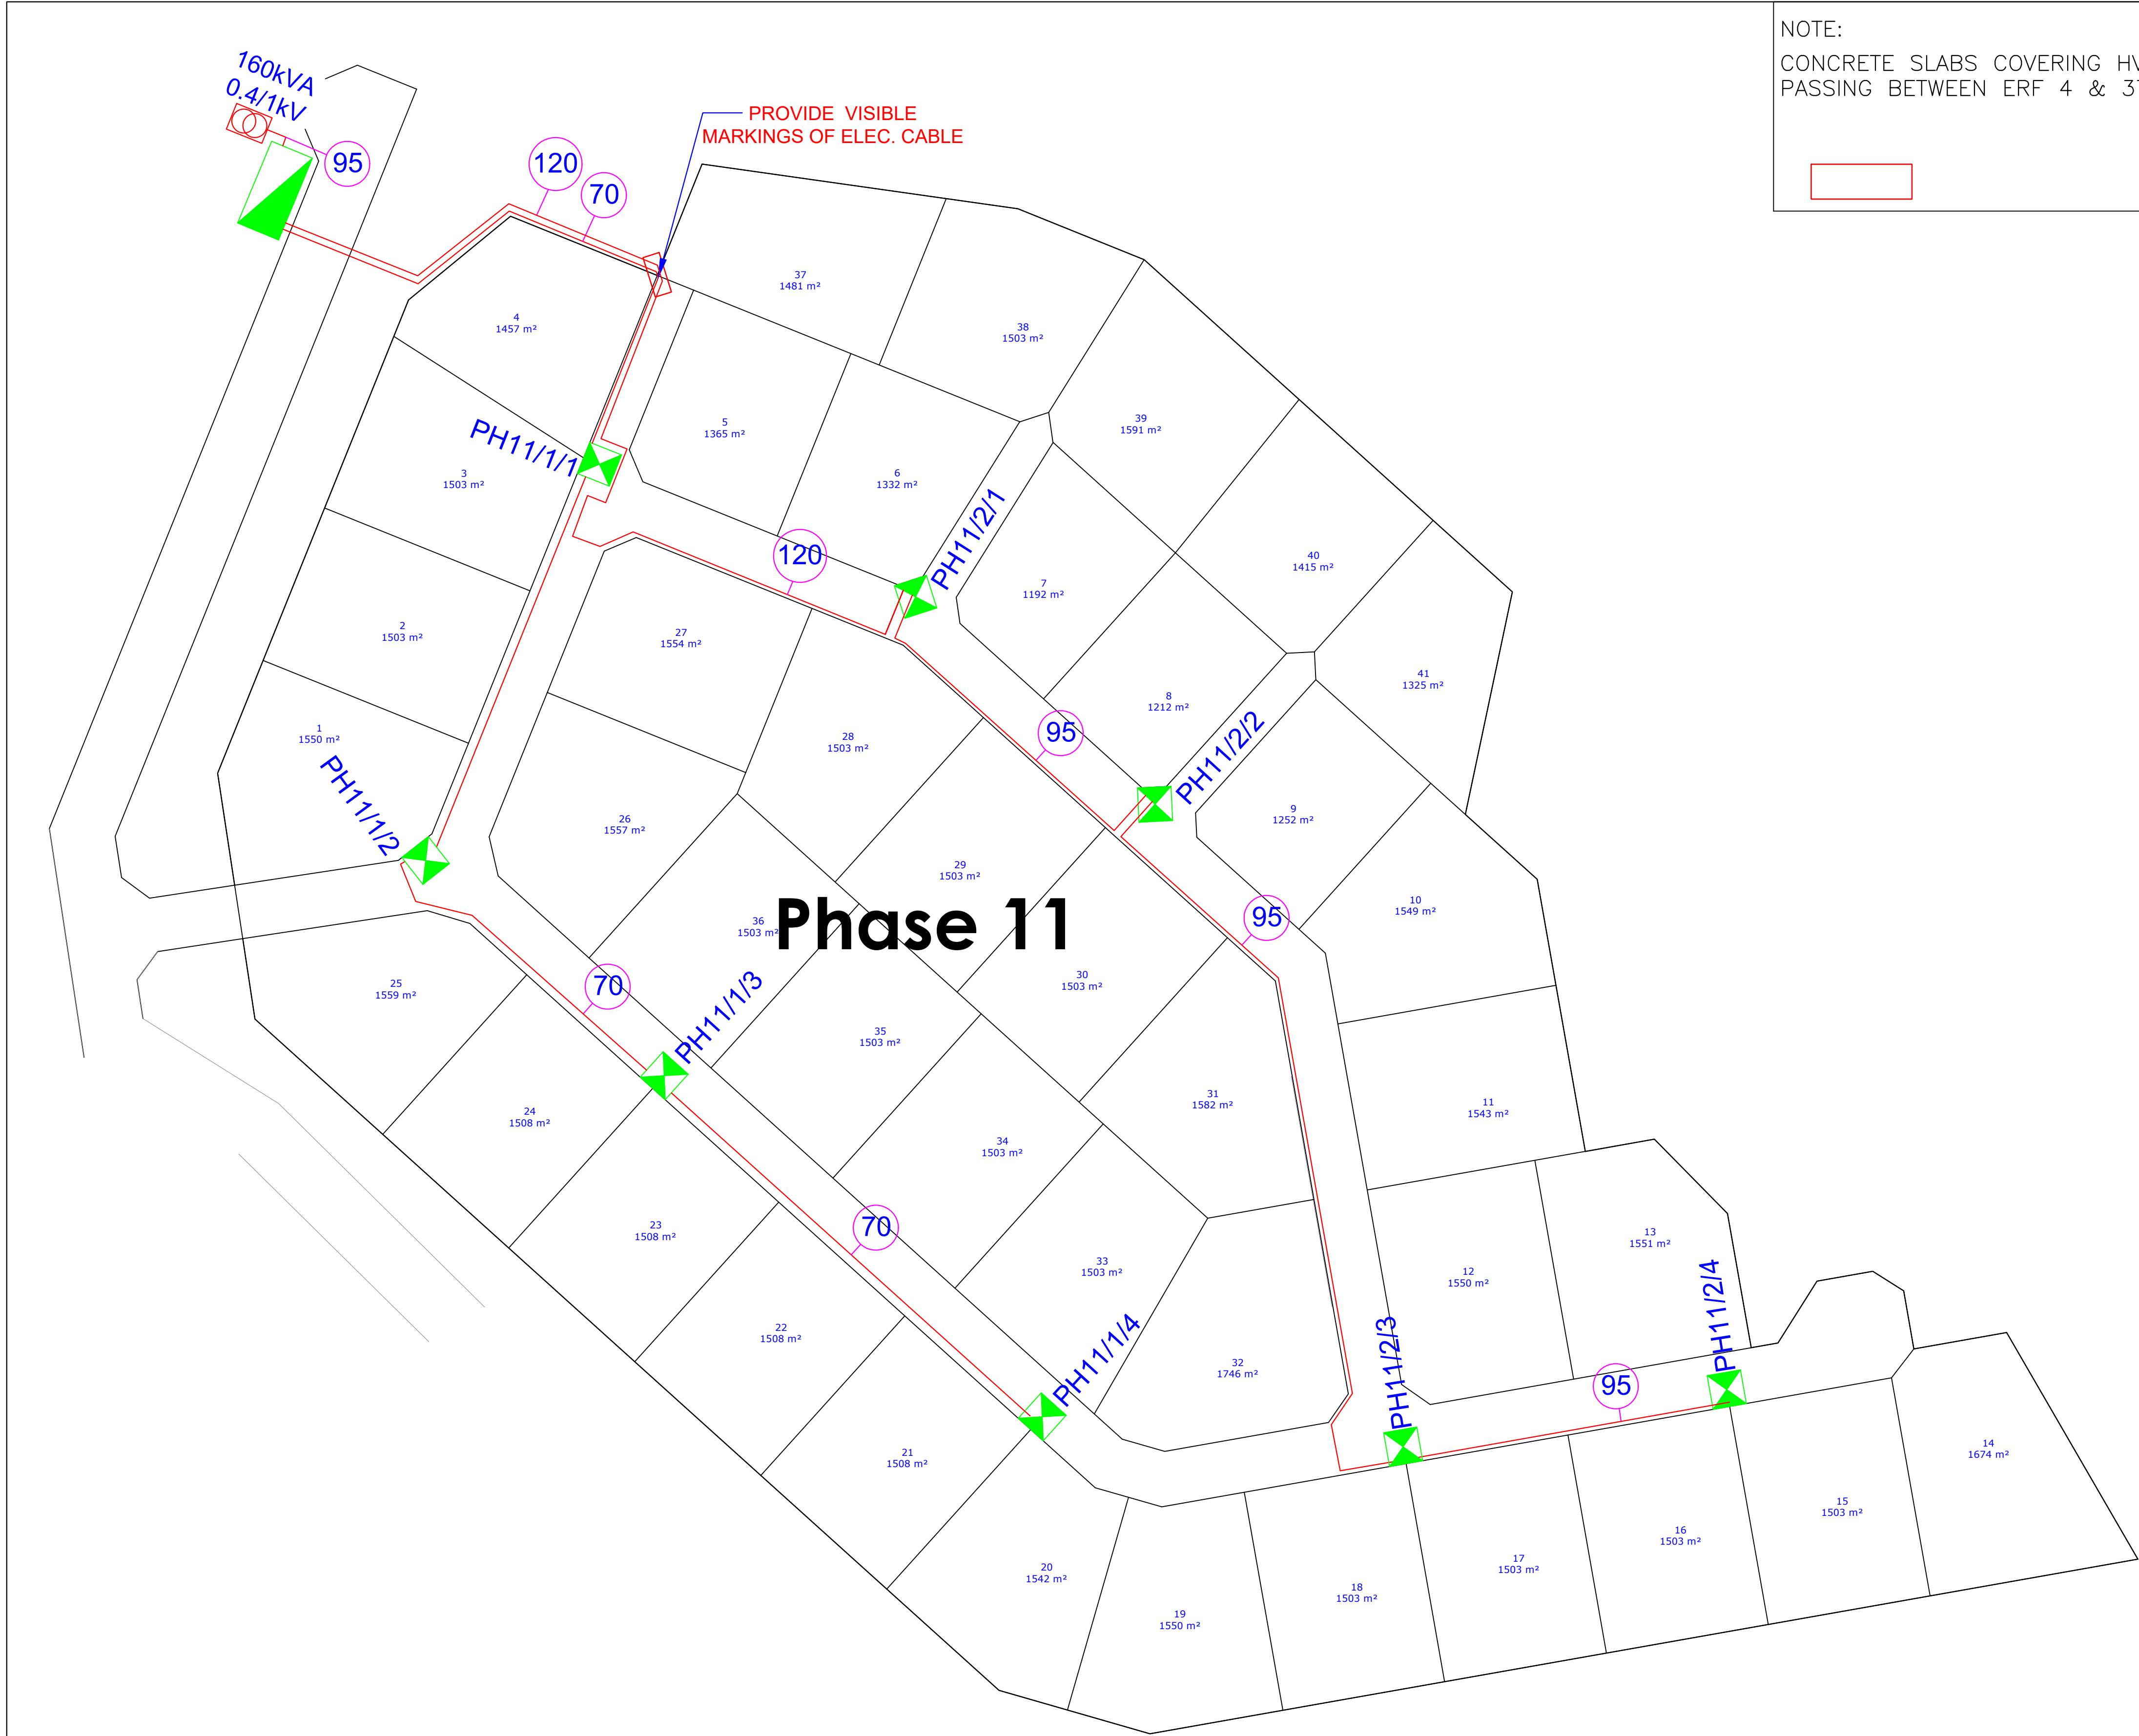

NOTE:
CONCRETE SLABS COVERING HV/LV CABLE
PASSING BETWEEN ERF 4 & 37 (PH11)

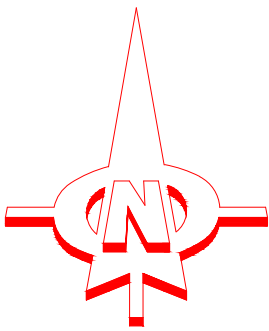

LEGEND:	
	MINI SUB
	NEW R.M.U
	KIOSK
	4Core Cu PVC SWA UNDERGROUND CABLE
	4Core Cu PVC SWA UNDERGROUND CABLE 95mm2
	4Core 1kV Cu PVC SWA UNDERGROUND CABLE



MOSSEL BAY
MUNICIPALITY



CVW MEGANIES EN ELEKTRIES
CVW MECHANICAL AND ELECTRICAL

RAADGEWENDE MECANIESE & ELEKTRIESE INGENIEURS
CONSULTING MECHANICAL & ELECTRICAL ENGINEERS

□ MOSSELBAAI P.O. BOX 281 HARTENBOS 6520 TEL. (044)6912074
□ BELVILLE P.O. BOX 1889 BELVILLE 7535 TEL. (021)9454501

PROJECT / PROJECT
OUTENIQUASBOSCH

TEKENING BESCHRYFING / DRAWING DESCRIPTION
LOW VOLTAGE LAYOUT
PHASE 11

TEKENING NR. / DRAWING NO.	REVISION
ME1589/11/2	AB

SKALA / SCALE	1:750 (A1)	WEGSAAM GECHEK / CHECKED	J.B. SNYMAN
LEEFYN: FILE N:	ME	DOOR WAAK: DOOR NAME	
DATUM: DATE	01/02/2022	GETEKEN: DRAWN	J.v.R.