



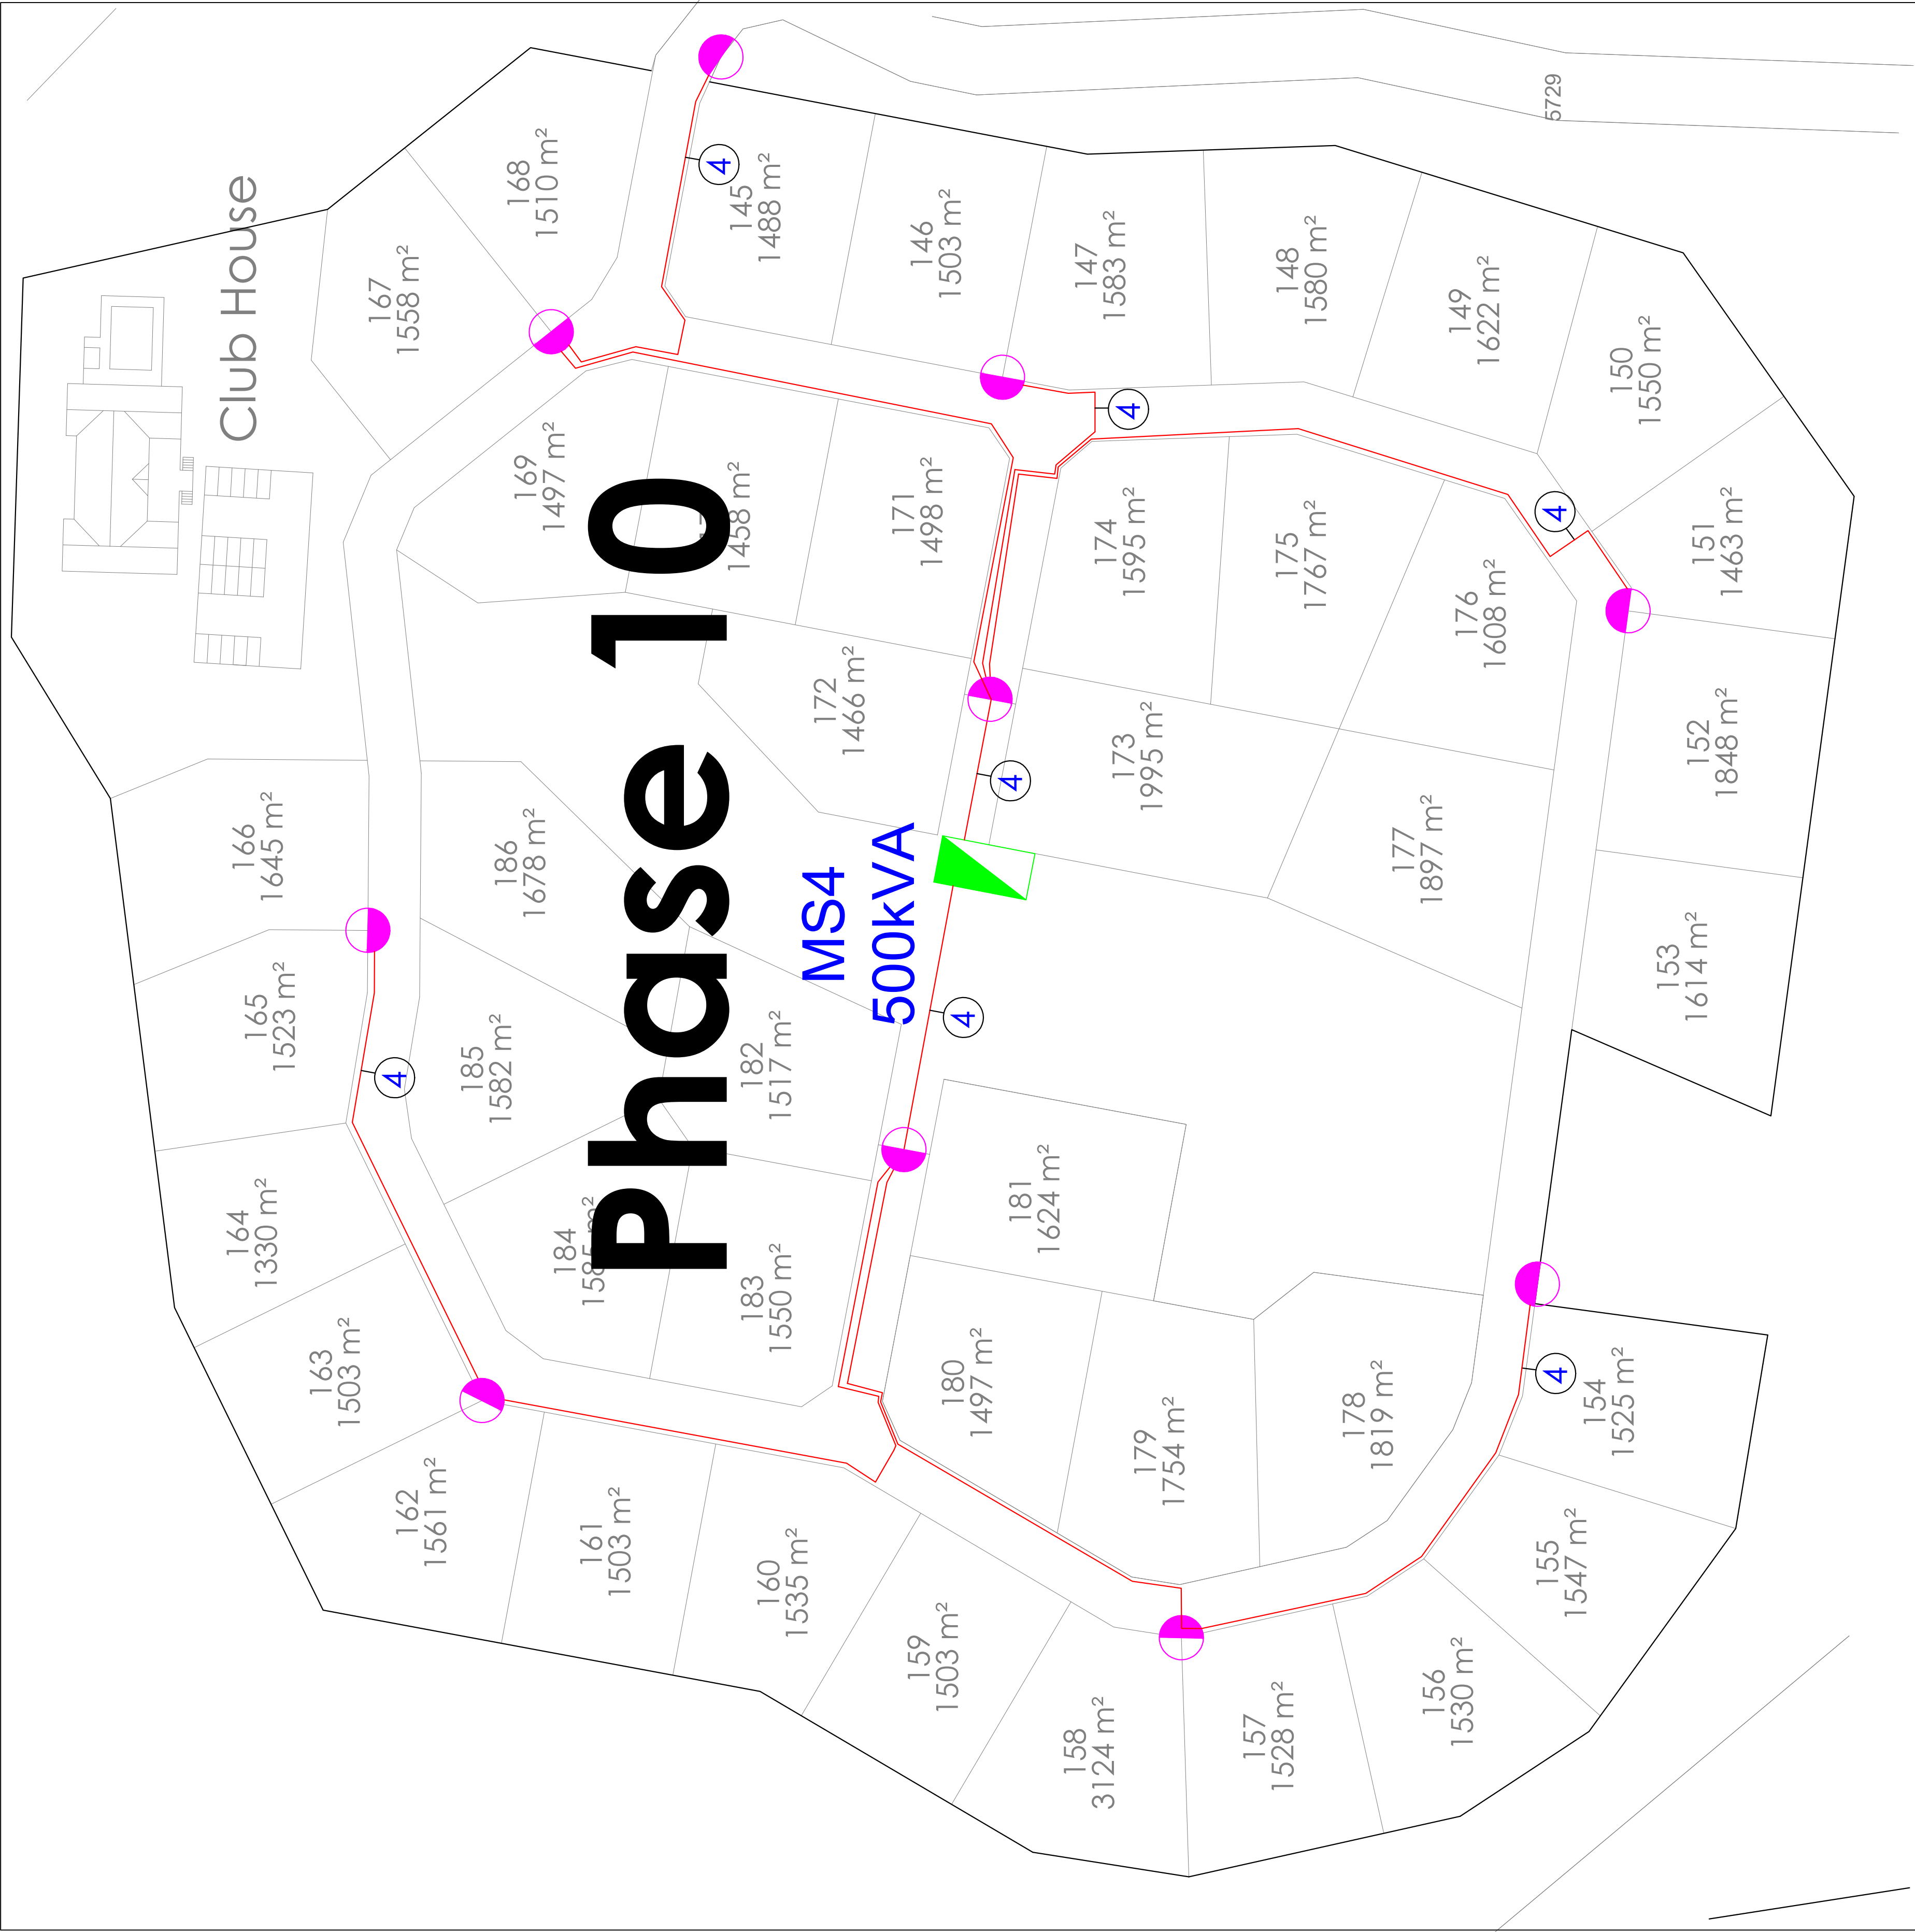

LEGEND:	
	MINI SUB
	NEW R.M.U
	STREET LIGHT
	2Core Cu PVC SWA UNDERGROUND CABLE
	2Core Cu PVC SWA UNDERGROUND CABLE 4mm2

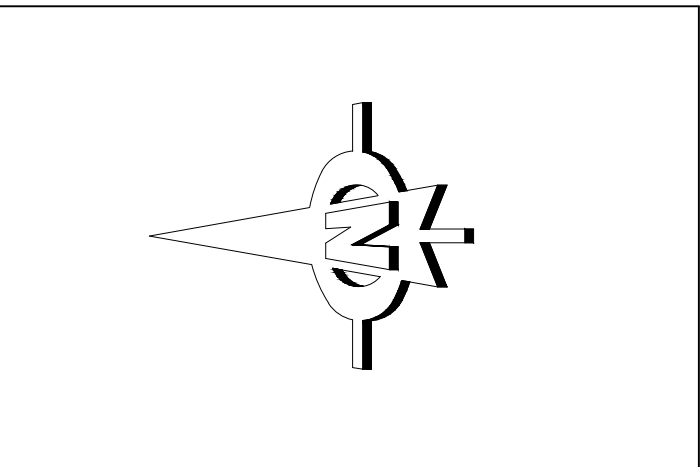

MOSSEL BAY
MUNICIPALITY



CVW
CVW MEGANIES EN ELEKTRIES
CVW MECHANICAL AND ELECTRICAL

RAADGEWENDE MEGANIESE & ELEKTRIESE INGENIEURS
CONSULTING MECHANICAL & ELECTRICAL ENGINEERS

□ MOSSELBAAI P.O. BOX 281 HARTENBOS 6520 TEL. (044)6912074
□ BELVILLE P.O. BOX 1889 BELVILLE 7535 TEL. (021)9454501

PROJ.EK / PROJECT
OUTENIKVASBOSCH

TEKENING BESRYFING / DRAWING DESCRIPTION
STREET LIGHTING LAYOUTS
PHASE 10

TEKENING NR. / DRAWING NO.		REVISION
ME1589/10/5		AB
AS BUILD		

SKAAL SCALE	1:750 (A1)	NAGEGAAN CHECKED	J.B. SNYMAN
LEER Nr. FILE No.	ME	CAD NAAM CAD NAME	
DATUM DATE	15/05/2019	GETEKEN DRAWN	J.v.R.