



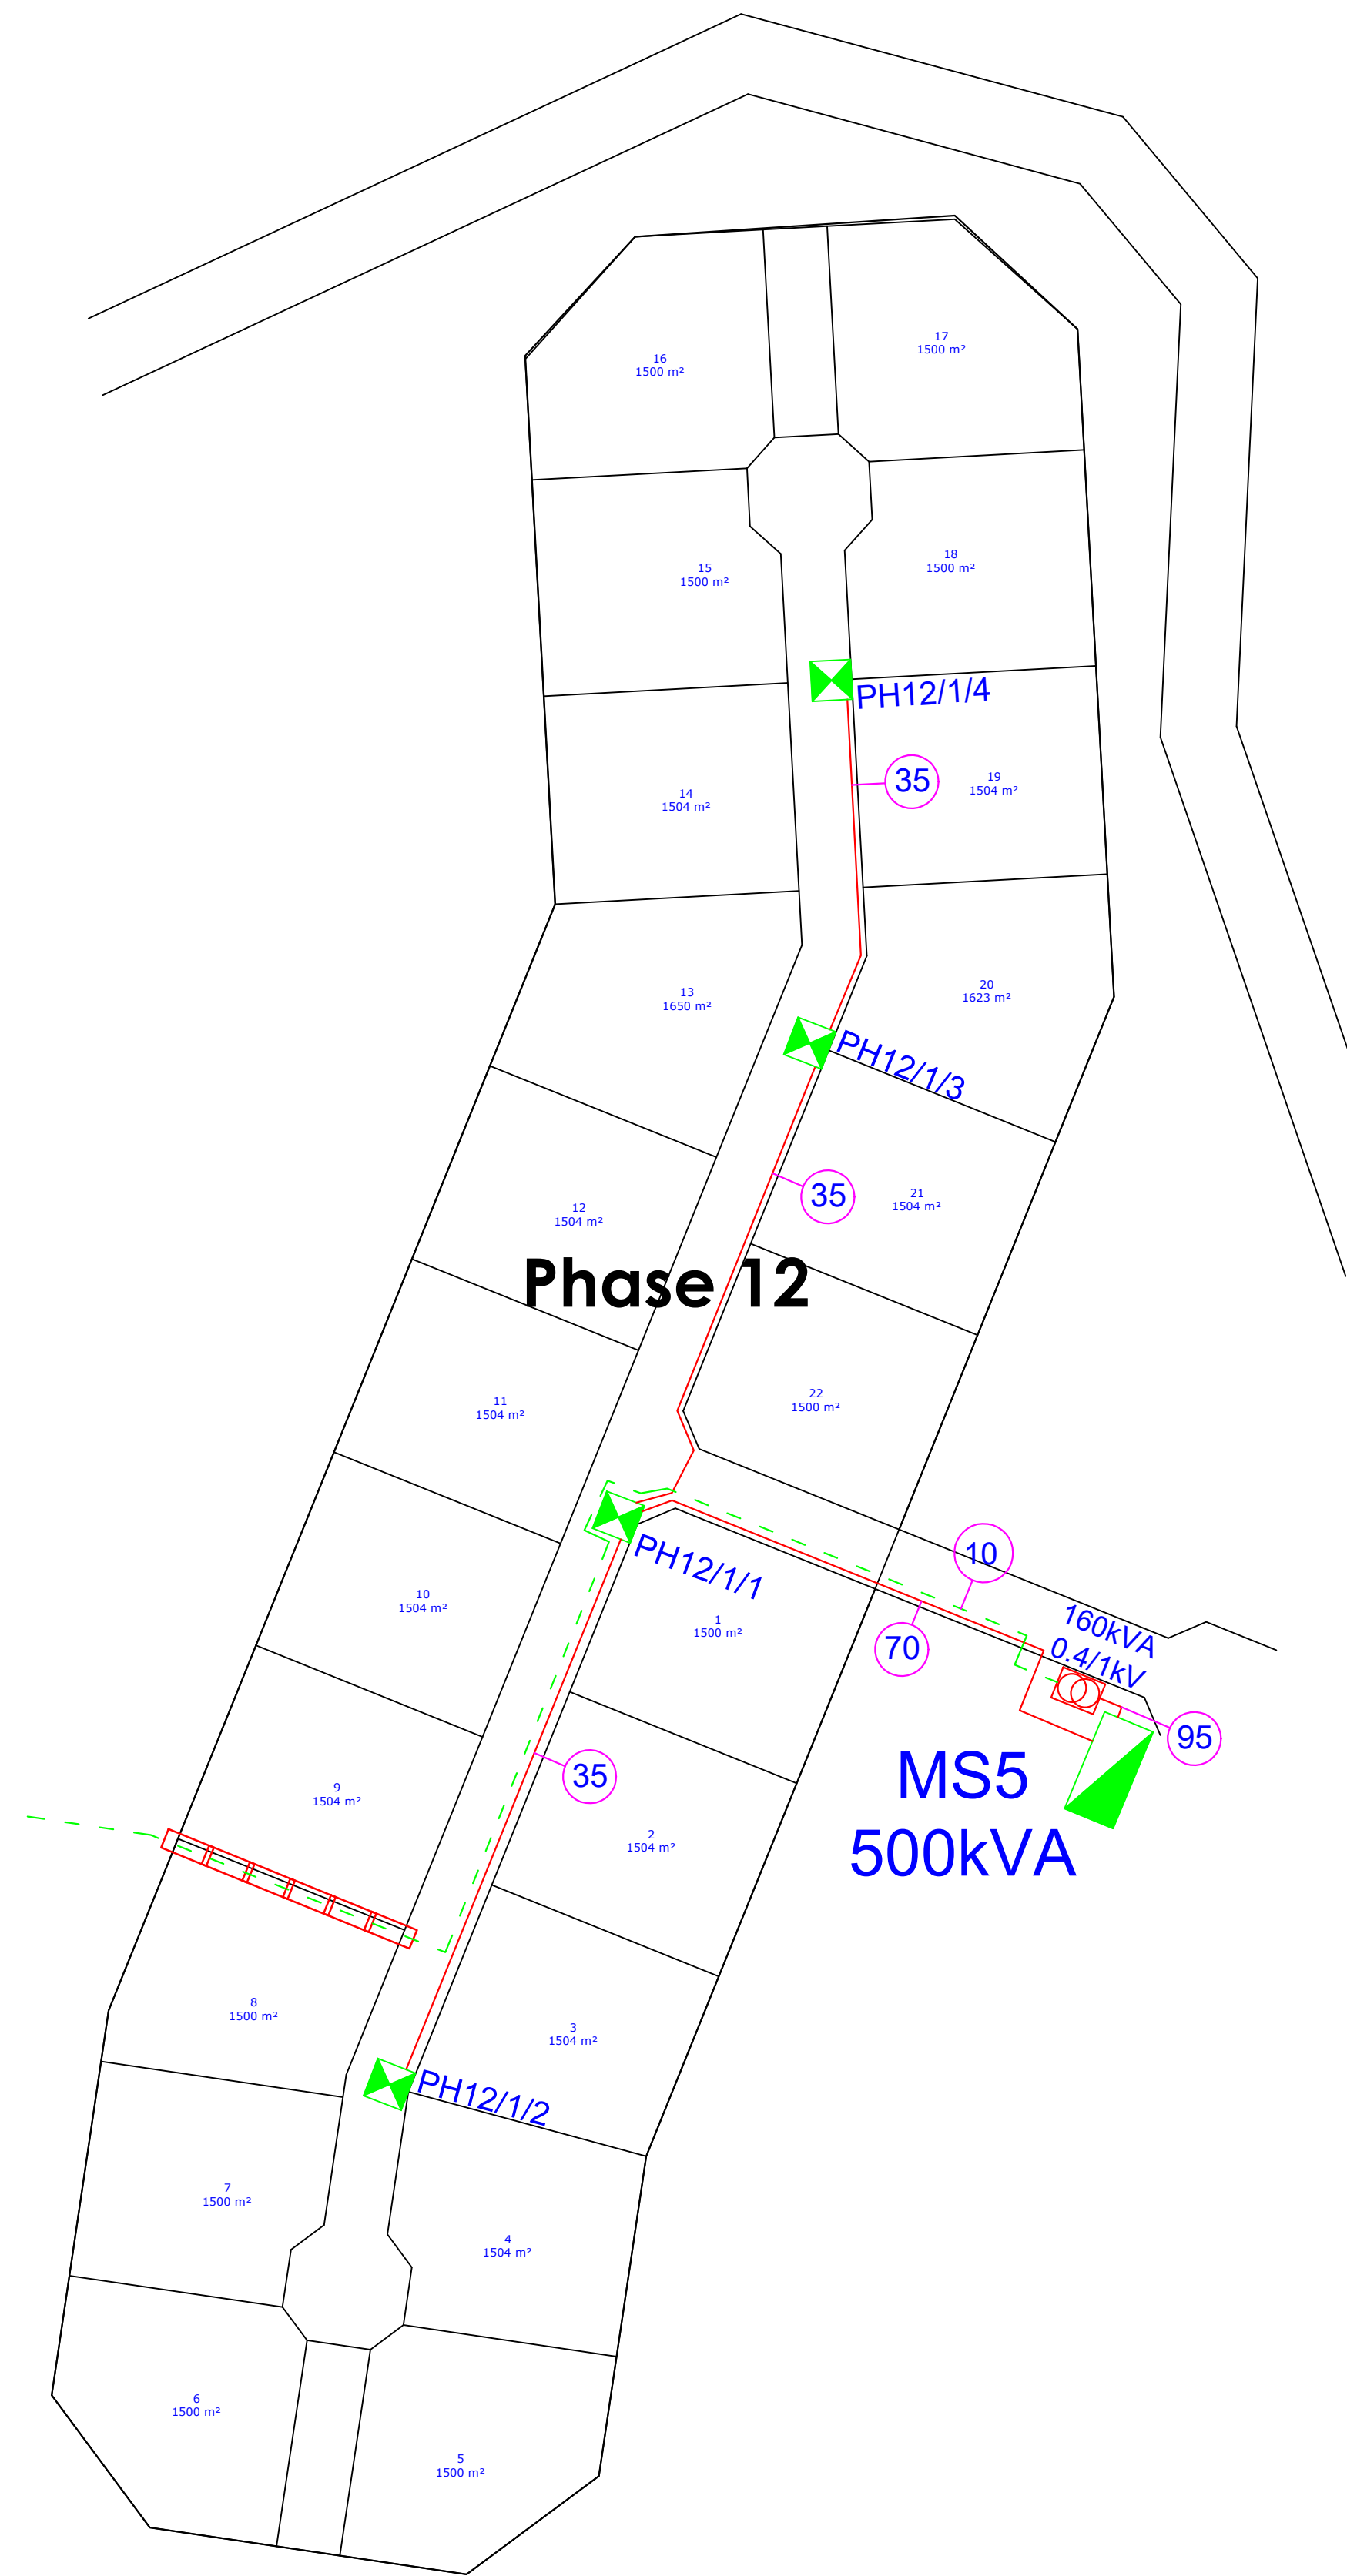

NOTE:
CONCRETE SLABS COVERING HV/LV CABLE
PASSING BETWEEN ERF 8 & 9 (PH12)

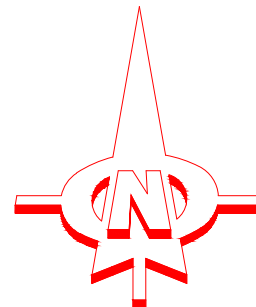

LEGEND:	
	MINI SUB
	NEW R.M.U
	KIOSK
	4Core Cu PVC SWA UNDERGROUND CABLE
	4Core Cu PVC SWA UNDERGROUND CABLE 95mm2
	4Core 1kV Cu PVC SWA UNDERGROUND CABLE



MOSSEL BAY
MUNICIPALITY



CVW
CVW MEGANIES EN ELEKTRIES
CVW MECHANICAL AND ELECTRICAL
RAADGEWENDE MEGANIESE & ELEKTRIESE INGENIEURS
CONSULTING MECHANICAL & ELECTRICAL ENGINEERS

□ MOSSELBAY

□ BELVILLE

P.O. BOX 281 HARTENBOS 6520

P.O. BOX 1889 BELVILLE 7535

TEL. (044)8912074

TEL. (021)9454501

PROJECT / PROJECT
OUTENIQUASBOSCH

TEKENING BESKRIVING / DRAWING DESCRIPTION
LOW VOLTAGE LAYOUT
PHASE 12

TEKENING NR. / DRAWING NO.	REVISION
ME1589/12/2	AB

SKALA / SCALE	1:1000 (A1)	INGEGENIEUR / CHECKED	J.B. SNYMAN
LEER Nr. / FILE No.	ME	OID NAAM / CAD NAME	
DATUM / DATE	01/02/2022	GETEKEN / DRAWN	J.v.R.