


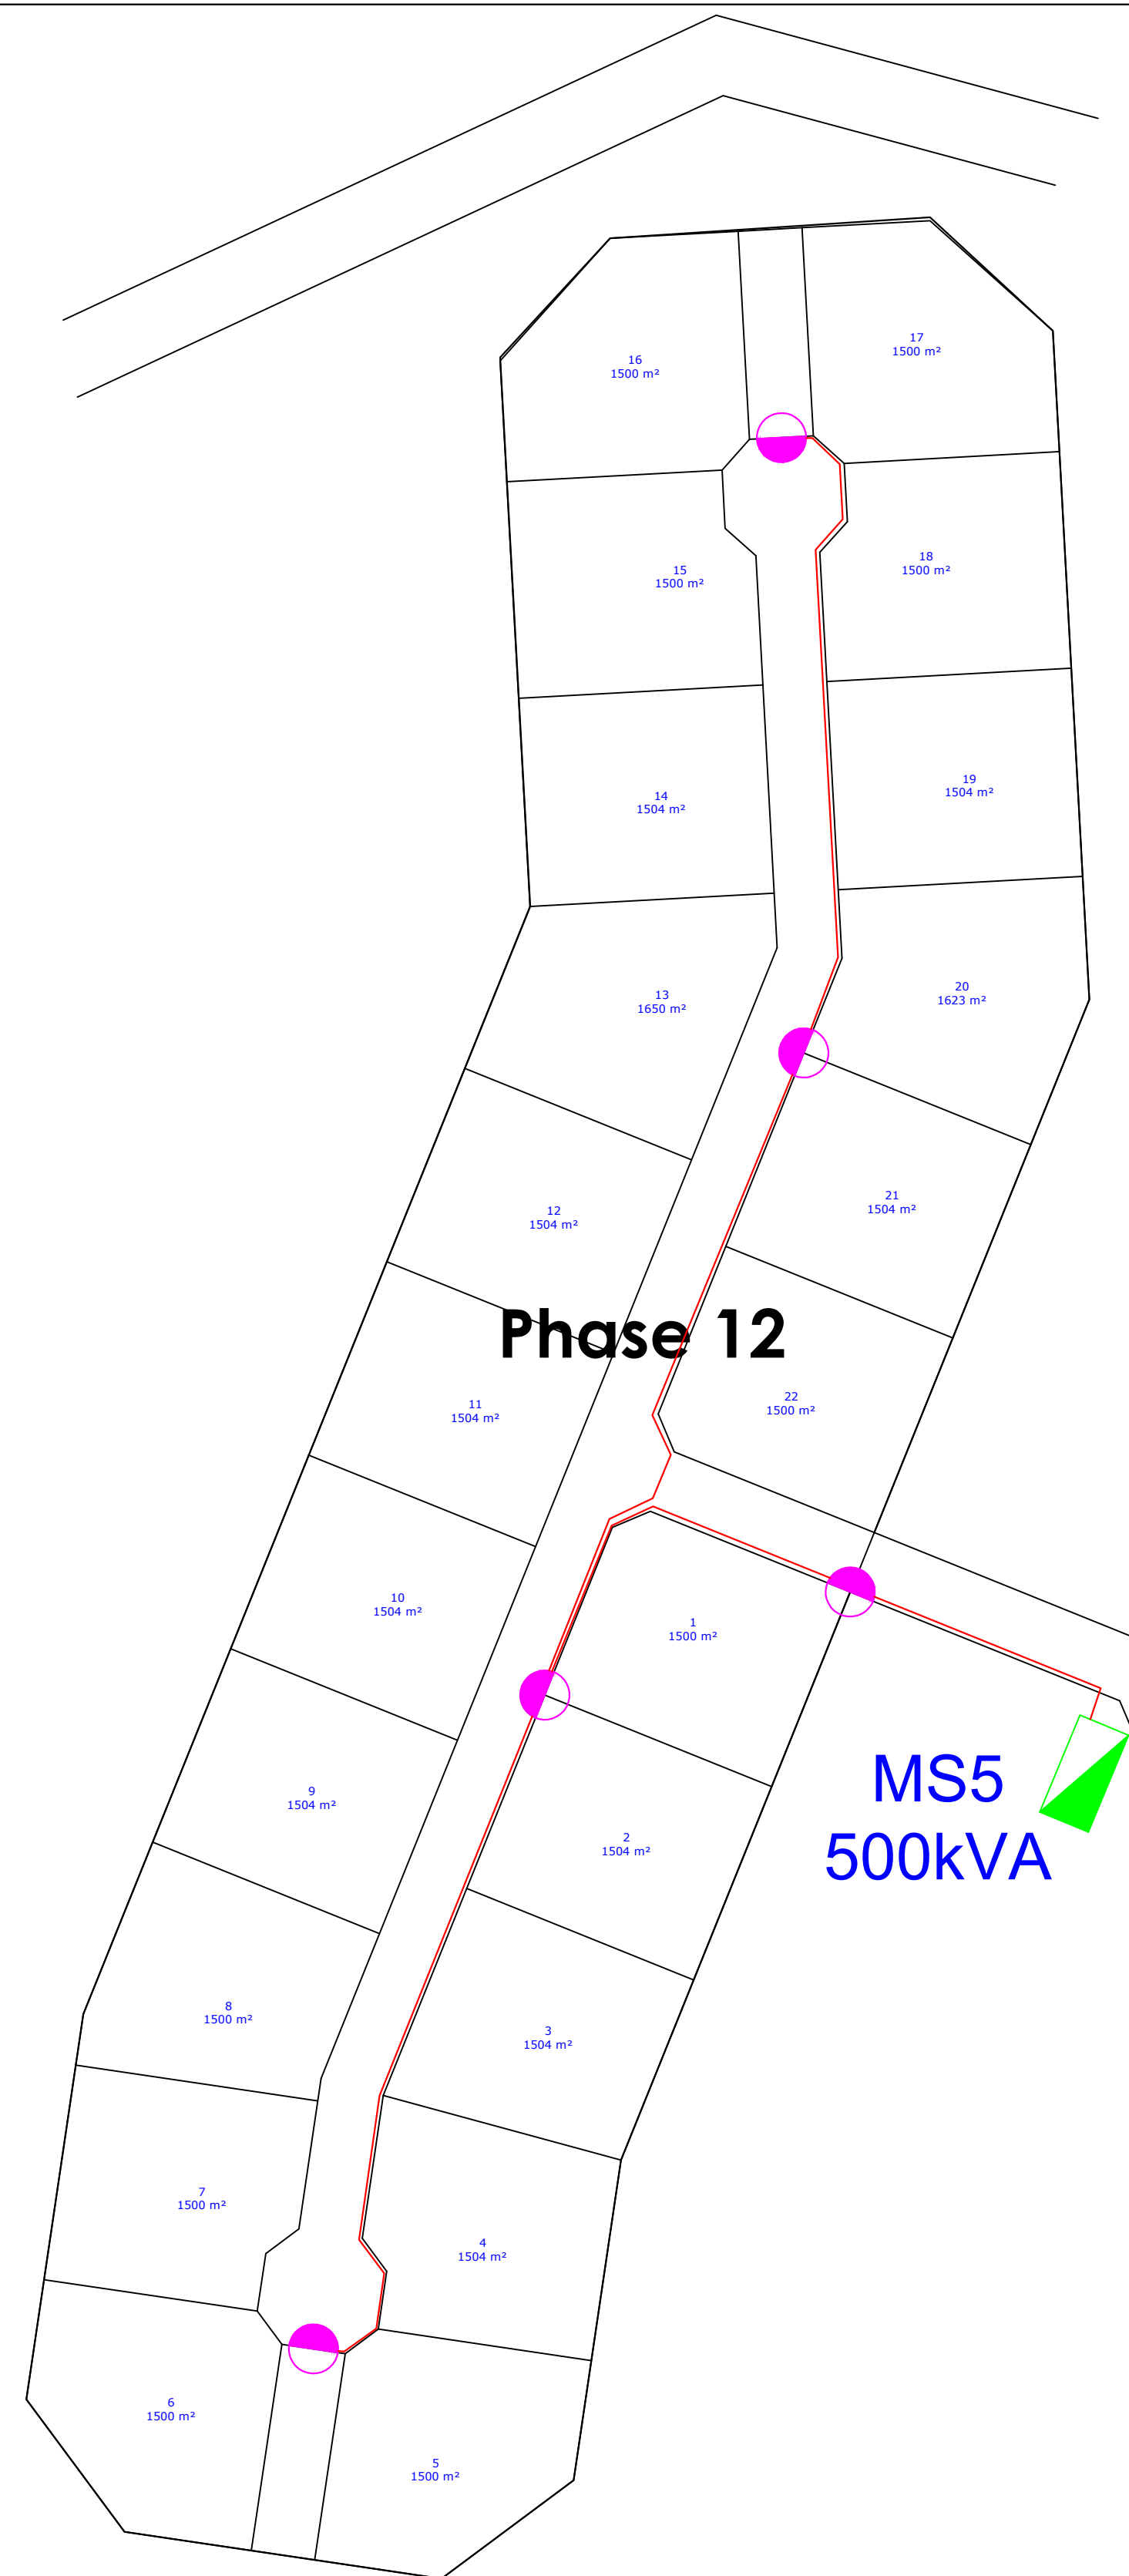

LEGEND:

	MINI SUB
	STREET LIGHT
	2Core Cu PVC SWA UNDERGROUND CABLE
	CABLE SIZE MARKER 4mm2

MOSSEL BAY
MUNICIPALITY

CVW
CVW MEGANIES EN ELEKTRIES
CVW MECHANICAL AND ELECTRICAL

RAADGEWENDE MEGANIESE & ELEKTRIESE INGENIEURS
CONSULTING MECHANICAL & ELECTRICAL ENGINEERS

MOSSELBAAI

BEUVILLE

P.O. BOX 281 HARTENBOS 6520 TEL. (044)6912074

P.O. BOX 1889 BEUVILLE 7535 TEL. (021)9454501

PROJEK / PROJECT
OUTENIQUASBOSCH

TEKENING BESKRYWING / DRAWING DESCRIPTION
STREET LIGHTING LAYOUT
PHASE 12

TEKENING NR. / DRAWING NO.
ME1589/12/5

REVISION
AB

SKAAL SCALE	1:1000 (A1)	NAEGGAAN CHECKED	J.B. SNYMAN
LEERIN FILE NO.	ME	CAD NAAM CAD NAME	
DATUM DATE	01/02/2022	GETEKEN DRAWN	J.v.R.