



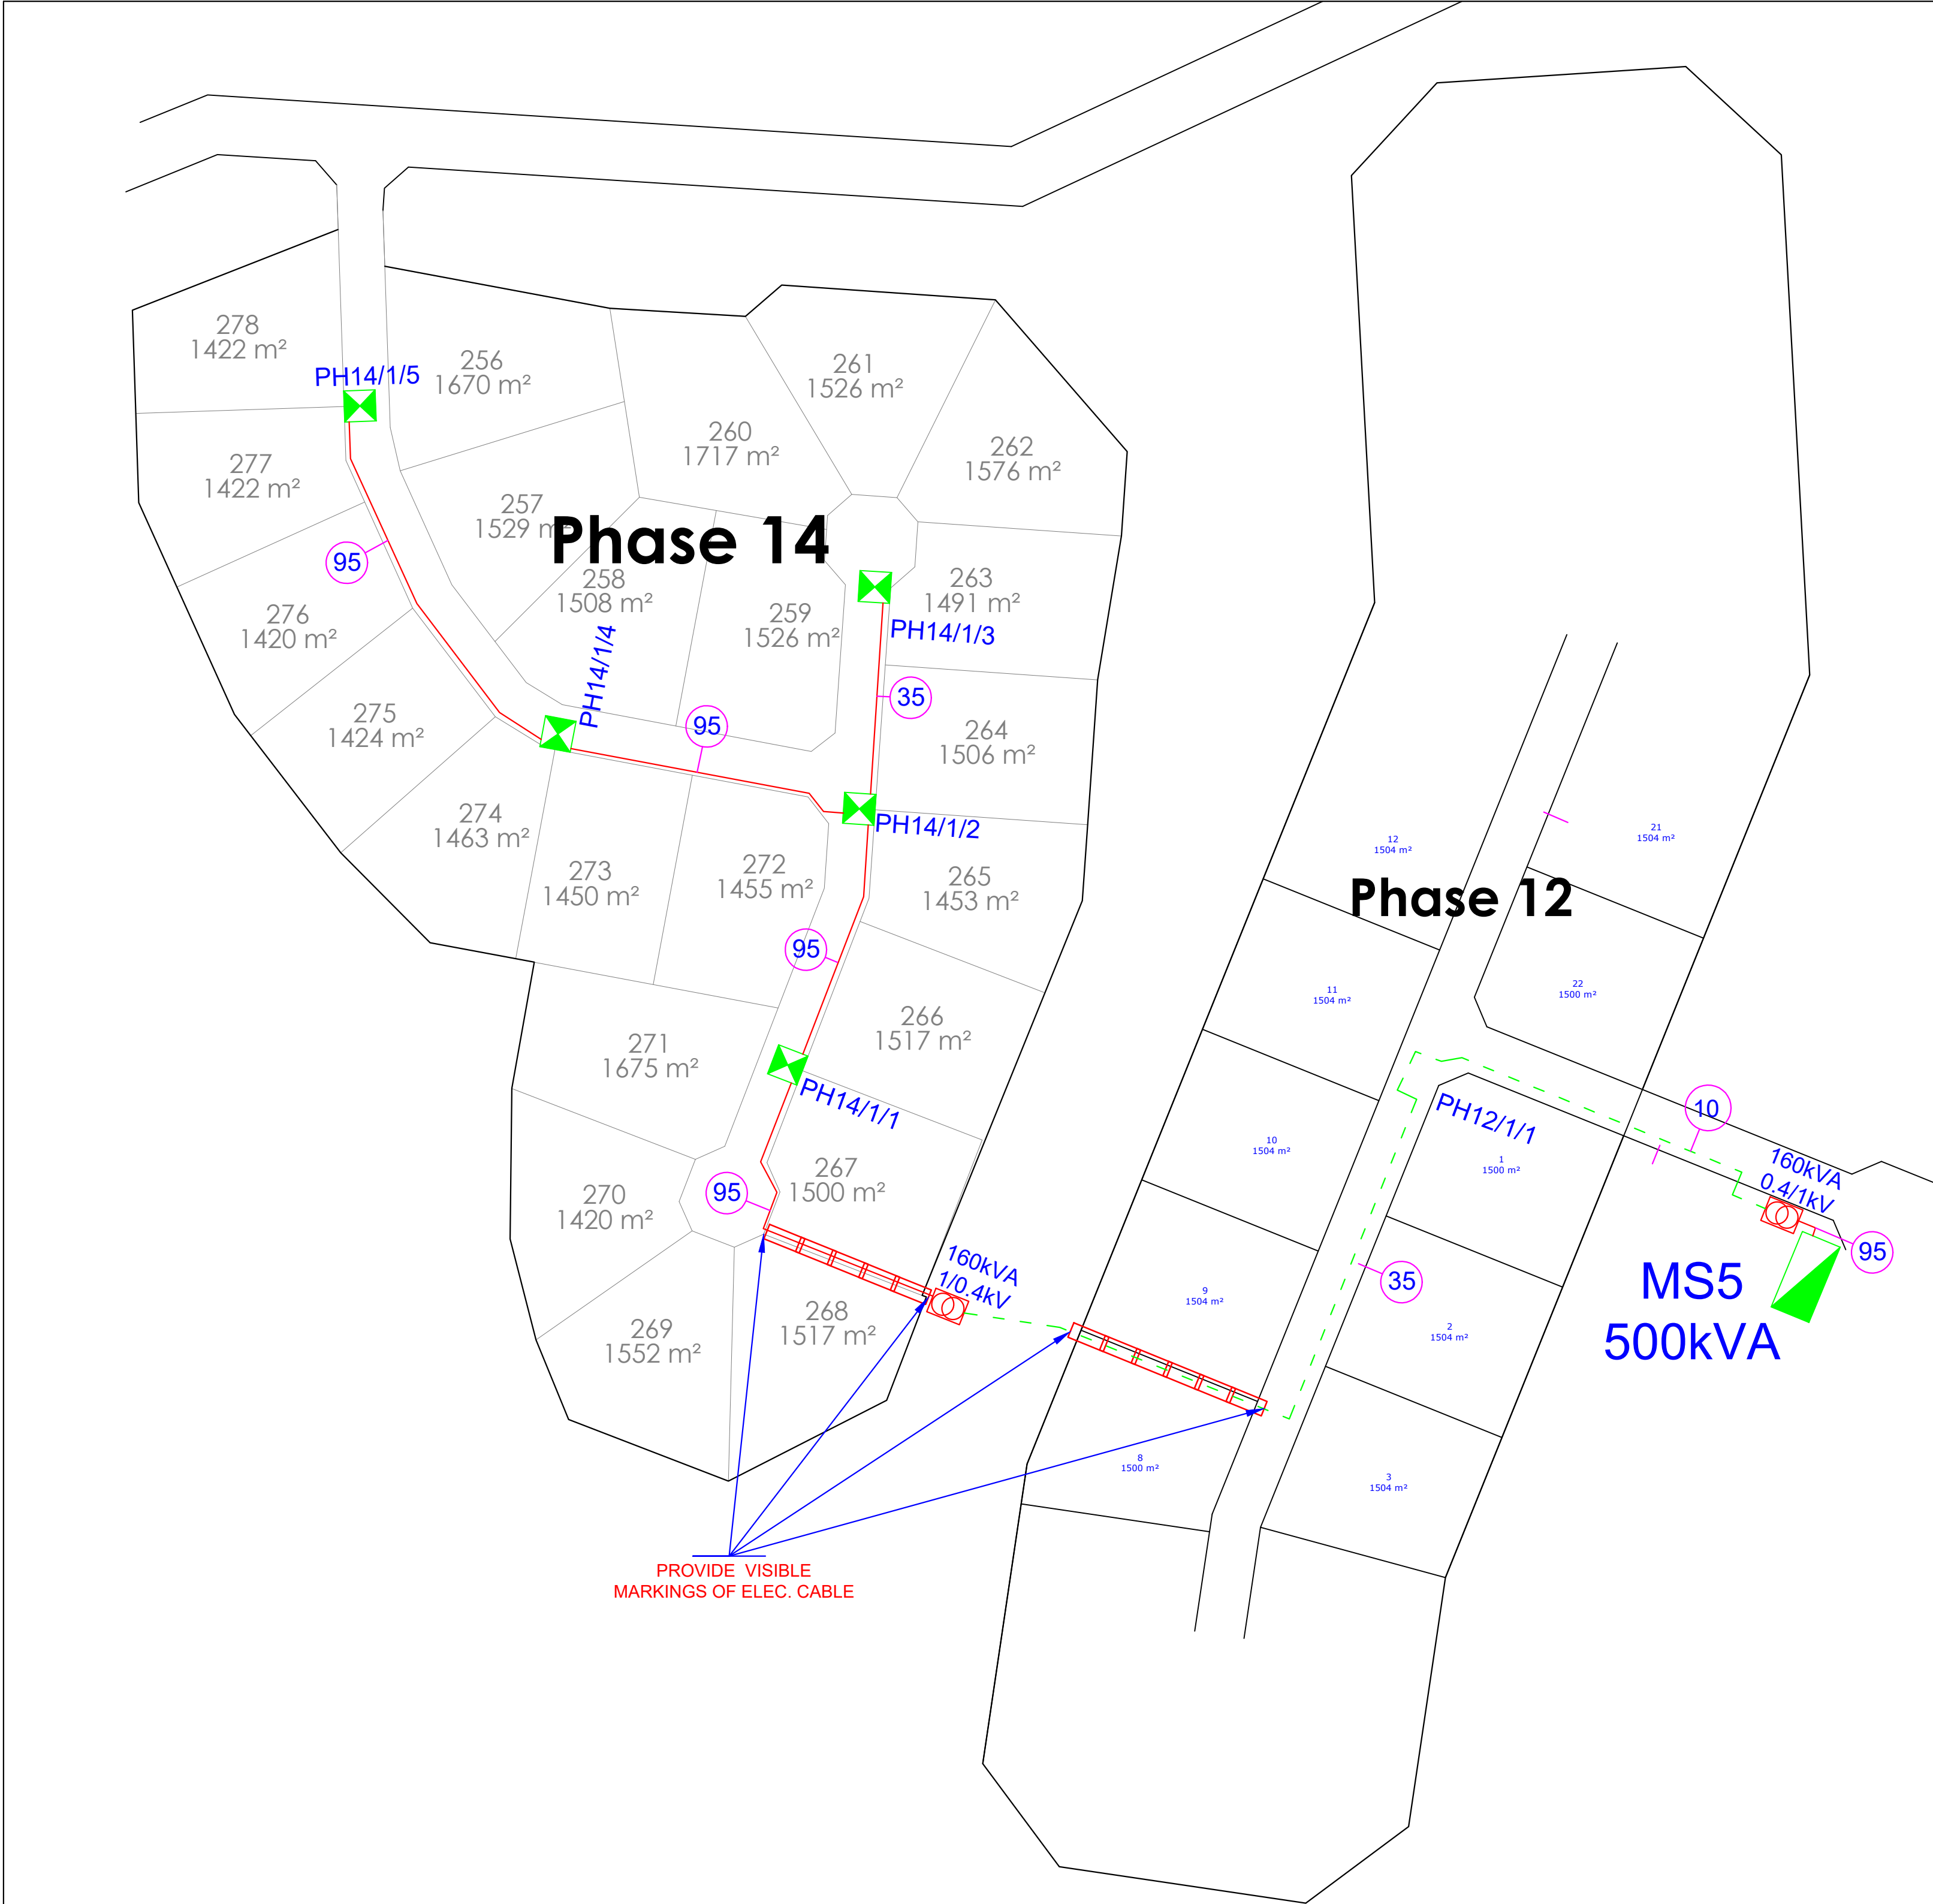

NOTE:
CONCRETE SLABS COVERING HV/LV CABLE

PASSING BETWEEN ERF 267 & 268 (PH14)

LEGEND:	
	MINI SUB
	NEW R.M.U
	KIOSK
	4Core Cu PVC SWA UNDERGROUND CABLE
	4Core Cu PVC SWA UNDERGROUND CABLE 95mm2
	4Core 1kV Cu PVC SWA UNDERGROUND CABLE

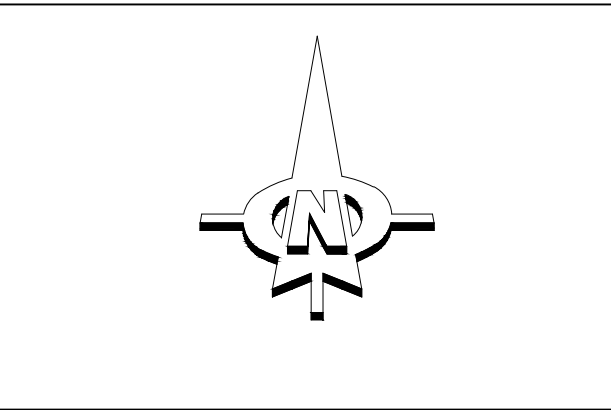

MOSSEL BAY
MUNICIPALITY



CW MEGANIES EN ELEKTRIES
CW MECHANICAL AND ELECTRICAL

RAADGEWENDE MEGANIESE & ELEKTRIESE INGENIEURSB
CONSULTING MECHANICAL & ELECTRICAL ENGINEERS

□ MOSSELBAY P.O. BOX 281 HARTENBOS 6520 TEL. (044)6912074
□ BELVILLE P.O. BOX 1889 BELVILLE 7535 TEL. (021)9454501

PROJ./PROJECT
OUTENIKUASBOSCH

TEDNING REKRYFING /DRAWING DESCRIPTION
LOW VOLTAGE LAYOUT
PHASE 14

TECHNIG NR. /DRAWING NO.	REVISION
ME1589/14/2	AB

BRAL SCALE	1:1000 (A1)	MAKESGAM CHECKED	J.B. SNYMAN
LEER NR.	ME	GO/NAAM	
DATE	01/02/2022	GETEKEN	J.v.R.