



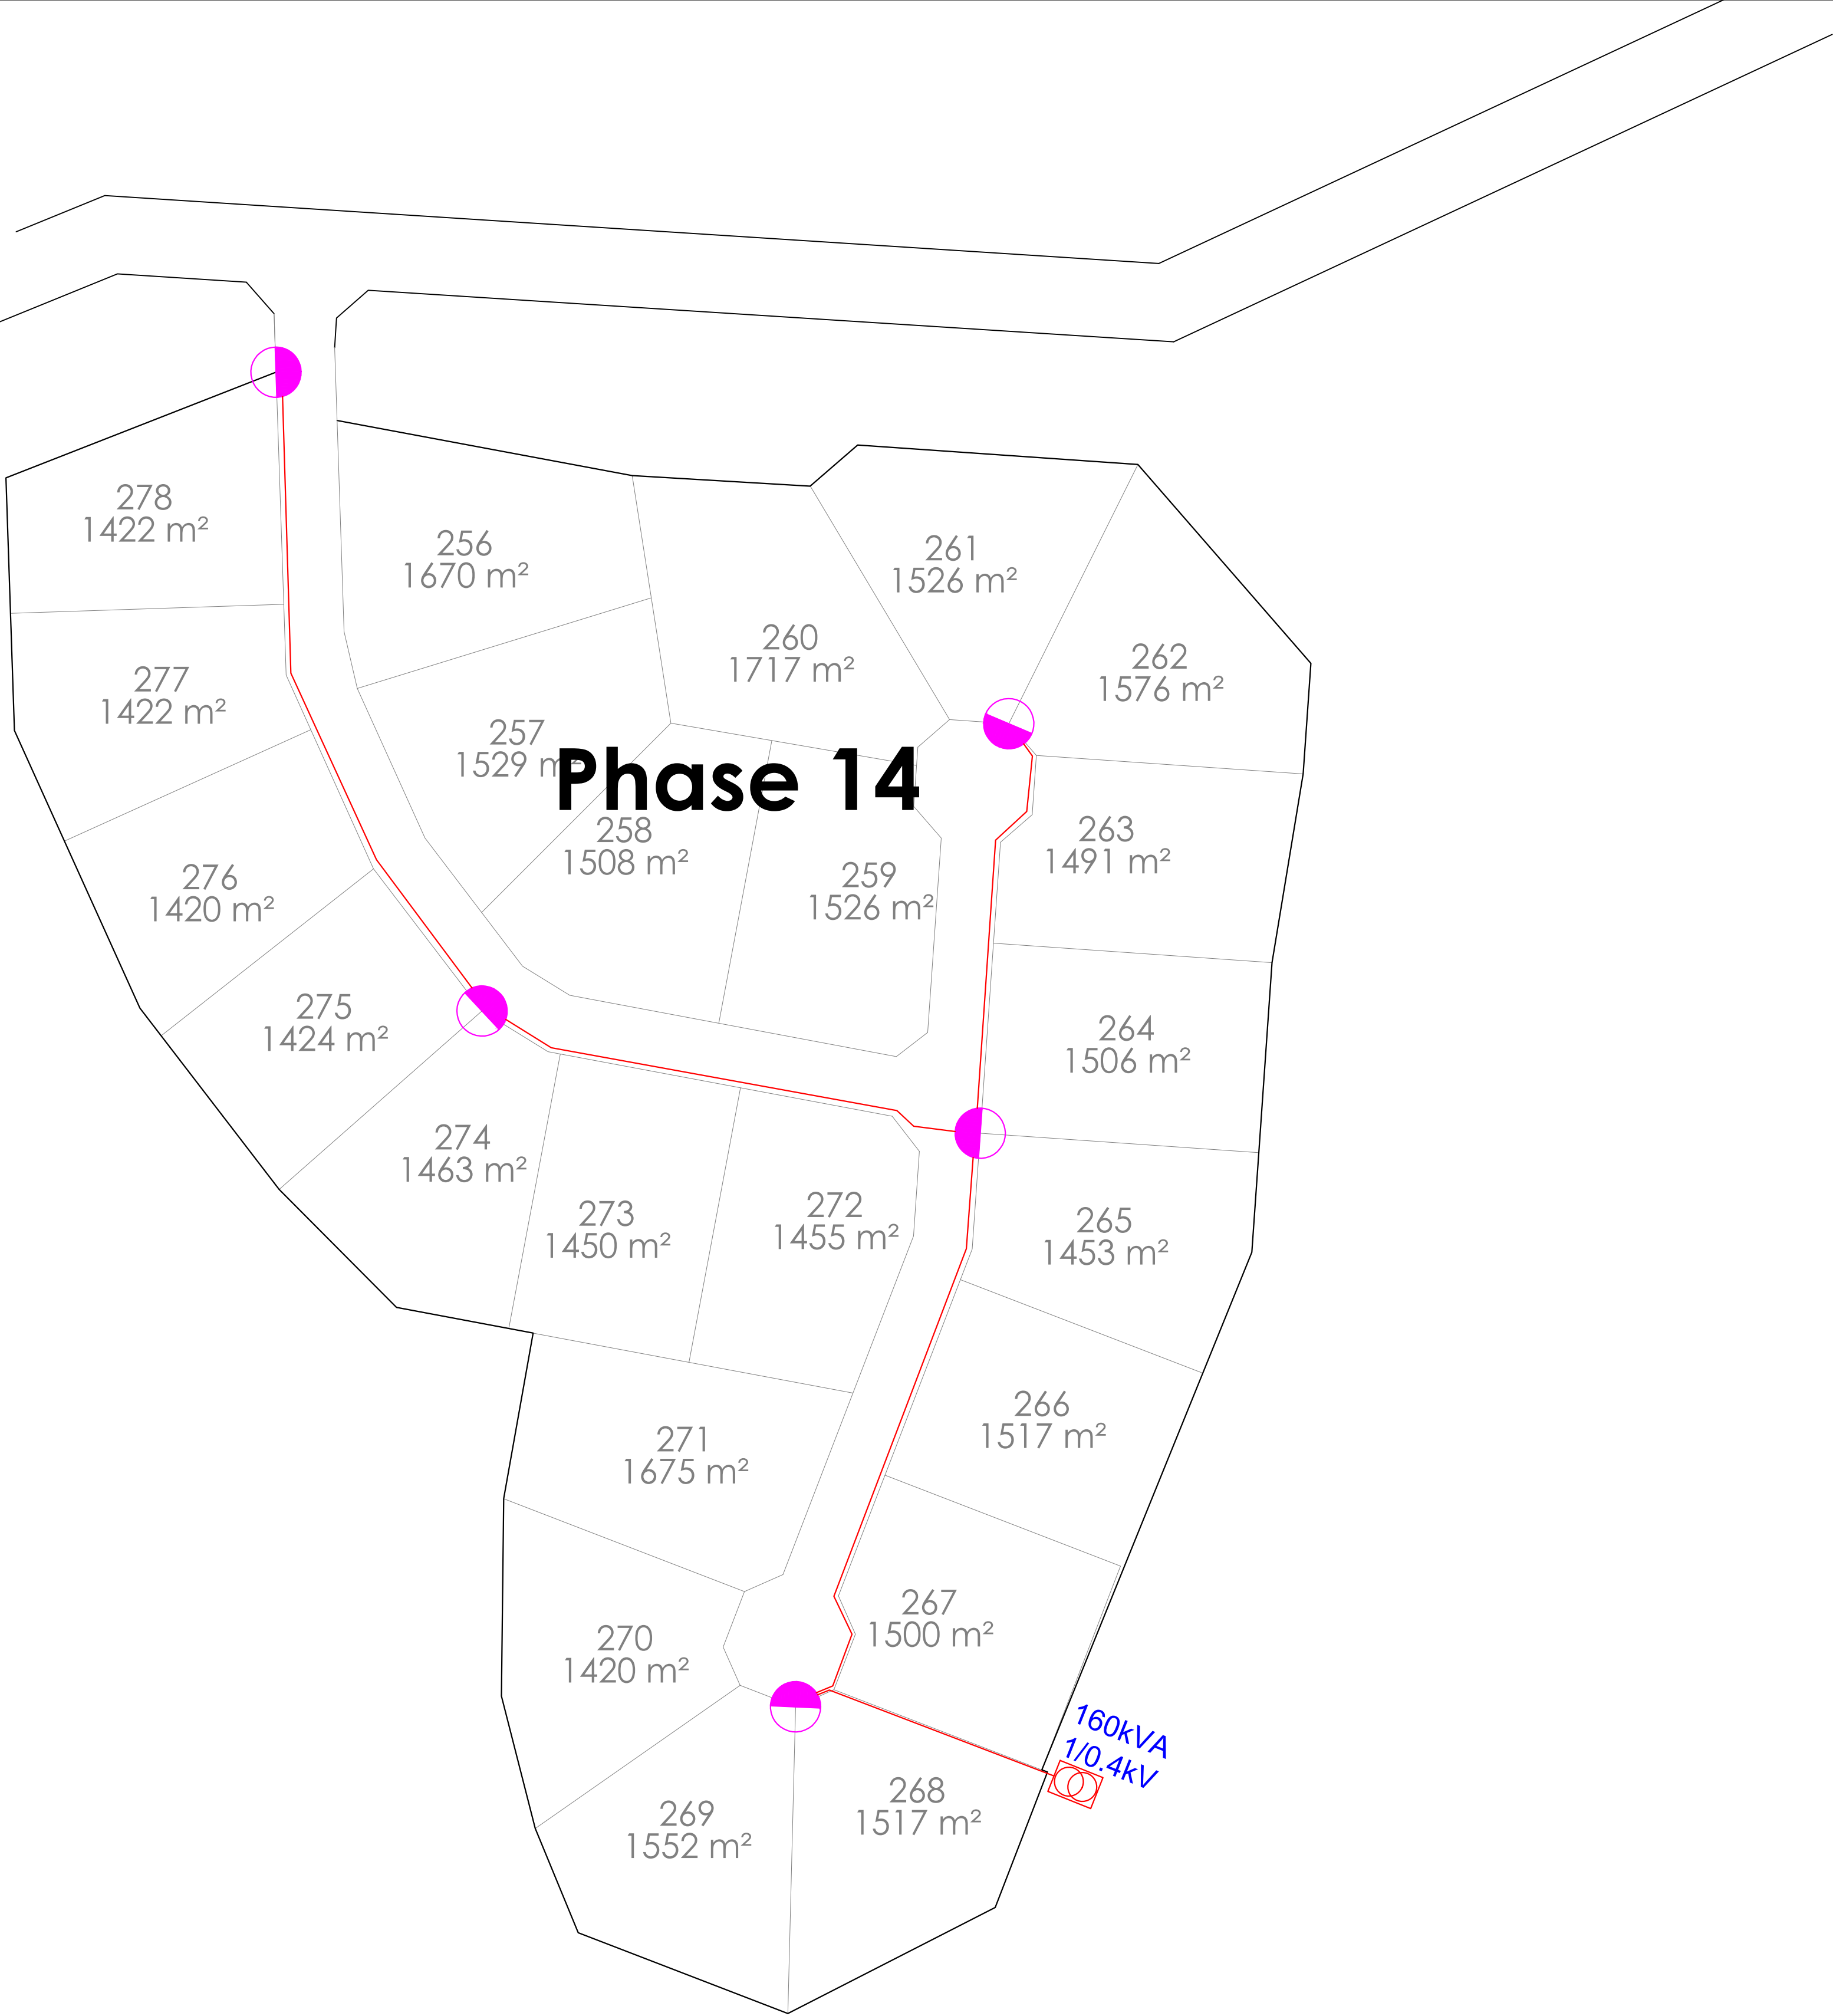

LEGEND:	
	MINI SUB
	STREET LIGHT
	2Core Cu PVC SWA UNDERGROUND CABLE
	CABLE SIZE MARKER 4mm2

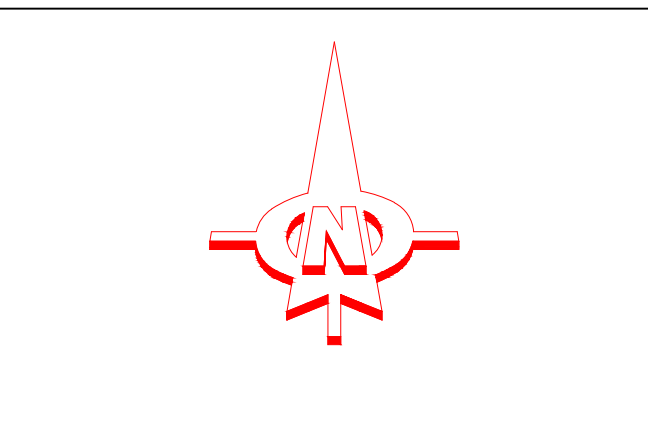

MOSSEL BAY
MUNICIPALITY



CVW
CVW MEGANIES EN ELEKTRIES
CVW MECHANICAL AND ELECTRICAL

RAADGEWENDE MEGANIESE & ELEKTRIESE INGENIEURS
CONSULTING MECHANICAL & ELECTRICAL ENGINEERS

□ MOSSELBAAI P.O. BOX 281 HARTENBOS 6520 TEL. (044)6912074
□ BELVILLE P.O. BOX 1889 BELVILLE 7535 TEL. (021)9454501

PROJEN / PROJECT
OUTENIQUASBOSCH

TENDERING BESKRYWING / DRAWING DESCRIPTION
STREET LIGHTING LAYOUT
PHASE 14

TENDERING NR. / DRAWING NO.	REVISION
ME1589/14/5	AB

SKAAL SCALE	1:1750 (A1)	INGESAAK CHECKED	J.B. SNYMAN
LEER IN FILE NO.	ME	OPDRAG JOB NAME	
DATUM DATE	01/02/2022	GETEKEN DRAWN	J.v.R.